



ELECTRICAL SYMBOLS	

SCHEDULE OF BEAMS AND SLABS				
Serial	Area	Bottom BEAM	Top	REINFORCE
B1	2' x 4"	200 mm dia 2 nos 12 mm dia	200 mm dia 2 nos 12 mm dia	5 mm dia 6" c/c
B2	2' x 6"	200 mm dia 2 nos 12 mm dia	200 mm dia 2 nos 12 mm dia	5 mm dia 6" c/c

SLABS			
Serial	Area	SPAN	REINFORCE
S1	4' x 4"	12 mm dia 6" c/c	12 mm dia 6" c/c
S2	5' x 5'	12 mm dia 6" c/c	8 mm dia 6" c/c
S3	5' x 5'	12 mm dia 6" c/c	8 mm dia 6" c/c

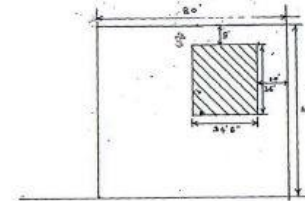


Room 120'

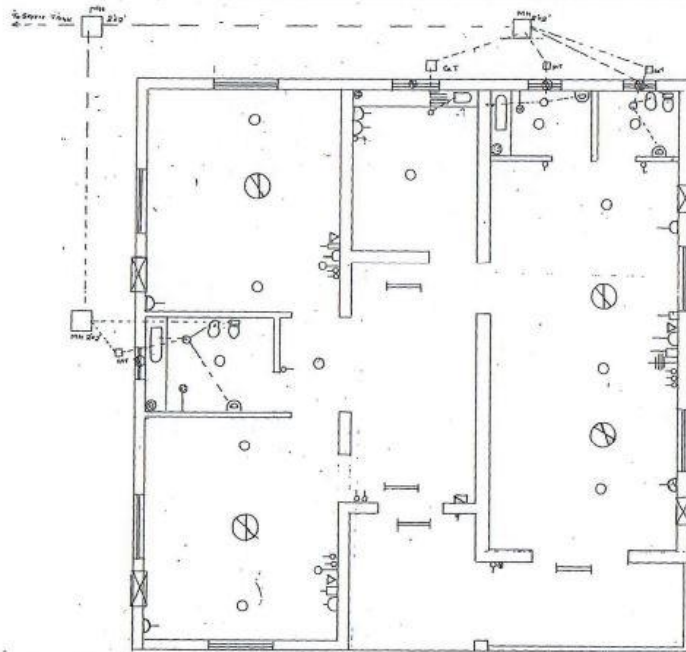

Note:- The standard size Siphon Tank and Siphon should be provided with the main floor-water tank for easy flow to the road.

23/4/77

ELECTRICAL AND DRAINAGE PLAN

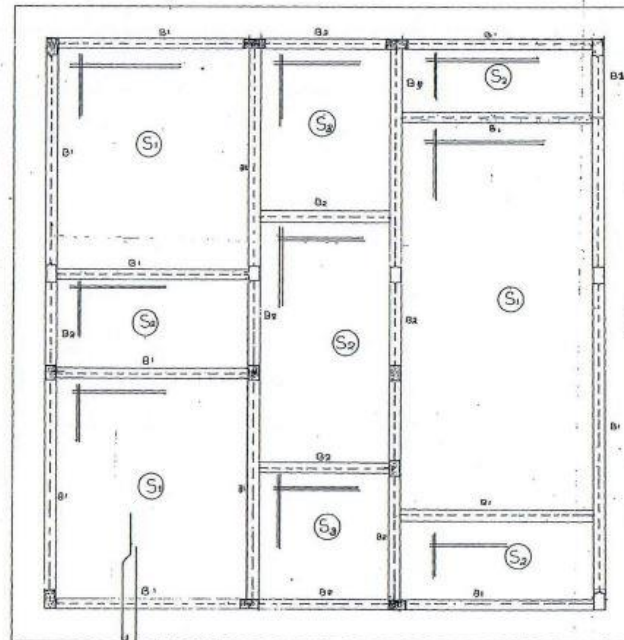

BEAM AND SLAB PLAN

BIN KHALDON TRAD
SHARJAH
U A E

PROPOSED VILLA FOR

PLOT NO: 644 BLOCK: OMKAND

DEPT BY: SCALE: 1" = 4'-0" DES: A



CHK BY: DATE: FOR: A

FOR MUNICIPAL USE



13/12/77

ENGINEER DIRECTOR
SHARJAH MUNICIPALITY
BUILDING APPLICATION No. VV/VV

ELECTRICAL AND DRAINAGE
BEAMS AND SLABS PLAN.

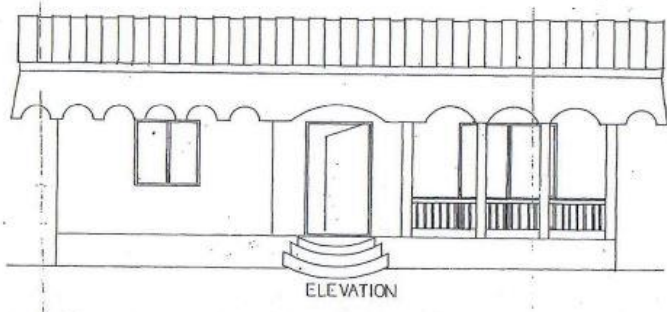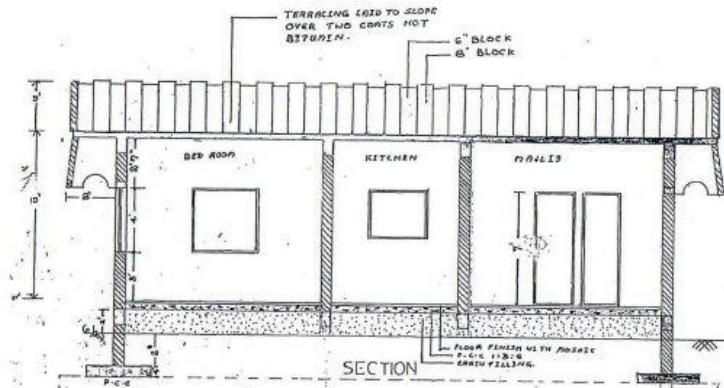

SCHEDULE OF DC		
Symbol	SIZE	DESCRIPTION
D	4' x 4'	TRUSS FOR SLAB D
D1	4' x 6'	ALUMINIUM SLAB
D2	6' x 7'	TRUSS FOR SLAB
D3	2'6" x 7'	TRUSS FOR SLAB
WINDOWS		
W1	4' x 4'	ALUMINIUM SLAB
W2	2' x 2'	ALUMINIUM SLAB
W3	4' x 5'	ALUMINIUM SLAB
SCHEDULE OF FC		
Symbol	SIZE	STEEL
F1	88' x 42' x 10'	12mm dia C.I.C.C
F2	4' x 4' x 4000'	12mm dia C.I.C.C
SCHEDULE OF COL		
Symbol	SIZE	STEEL
C1	8' x 10'	6mm dia 12mm dia
C2	8' x 12'	6mm dia 12mm dia

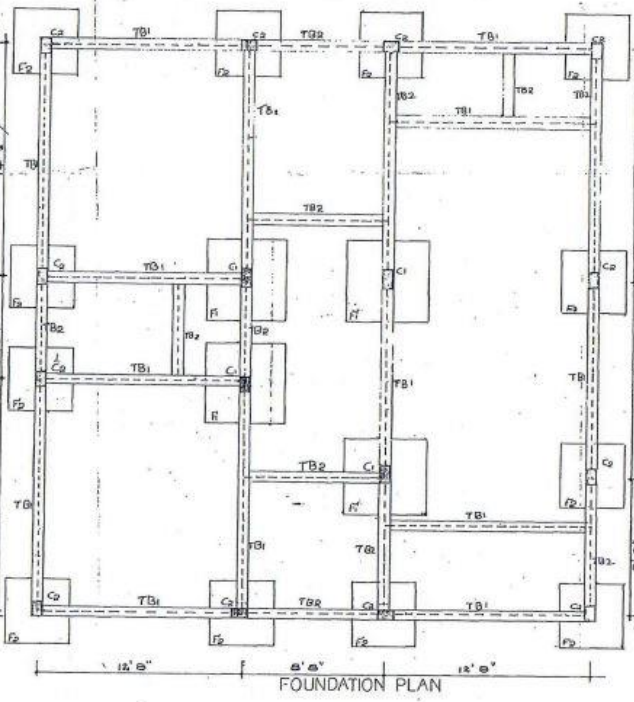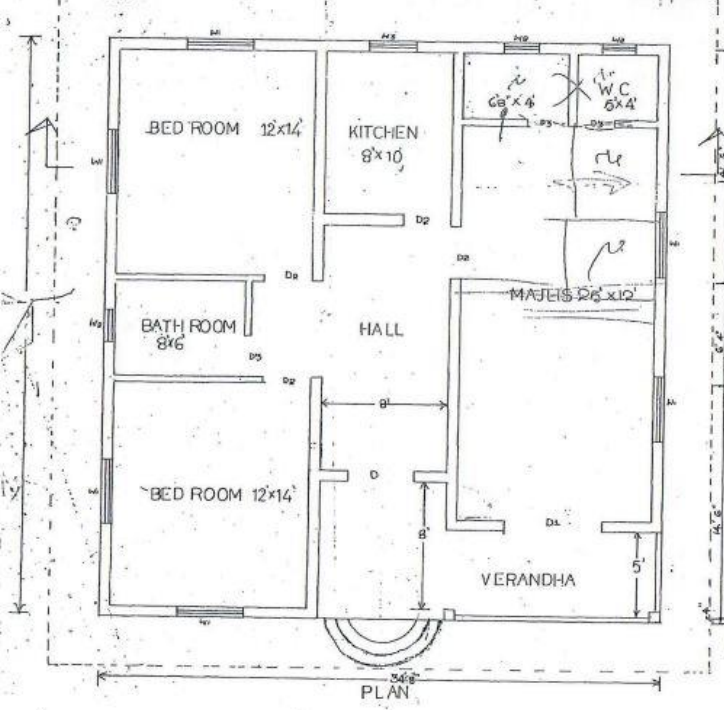

SCHEDULE OF PLINTH BE				
Symbol	SIZE	BOTTOM	DEAL	TOP
TB1	8' x 16'	2 nos 12mm dia	2 nos 12mm dia	2 nos 12mm dia
TB2	8' x 12'	2 nos 12mm dia	2 nos 12mm dia	2 nos 12mm dia

BIN KHALDON TRADING
SHARJAH
U. A. E.

PROPOSED VILLA FOR
PLOT NO: 644 BLOCK: ORKANDOR.

DELT BY	SCALE	DRG NO
CHK BY	DATE	TOB NO

FOR MUNICIPAL USE

12/10

MUNICIPAL DIRECTOR

SHARJAH MUNICIPALITY

W.P.V

HOUSING AUTHORITY SH.

PLAN, SECTION, ELEVATION, FOUND